



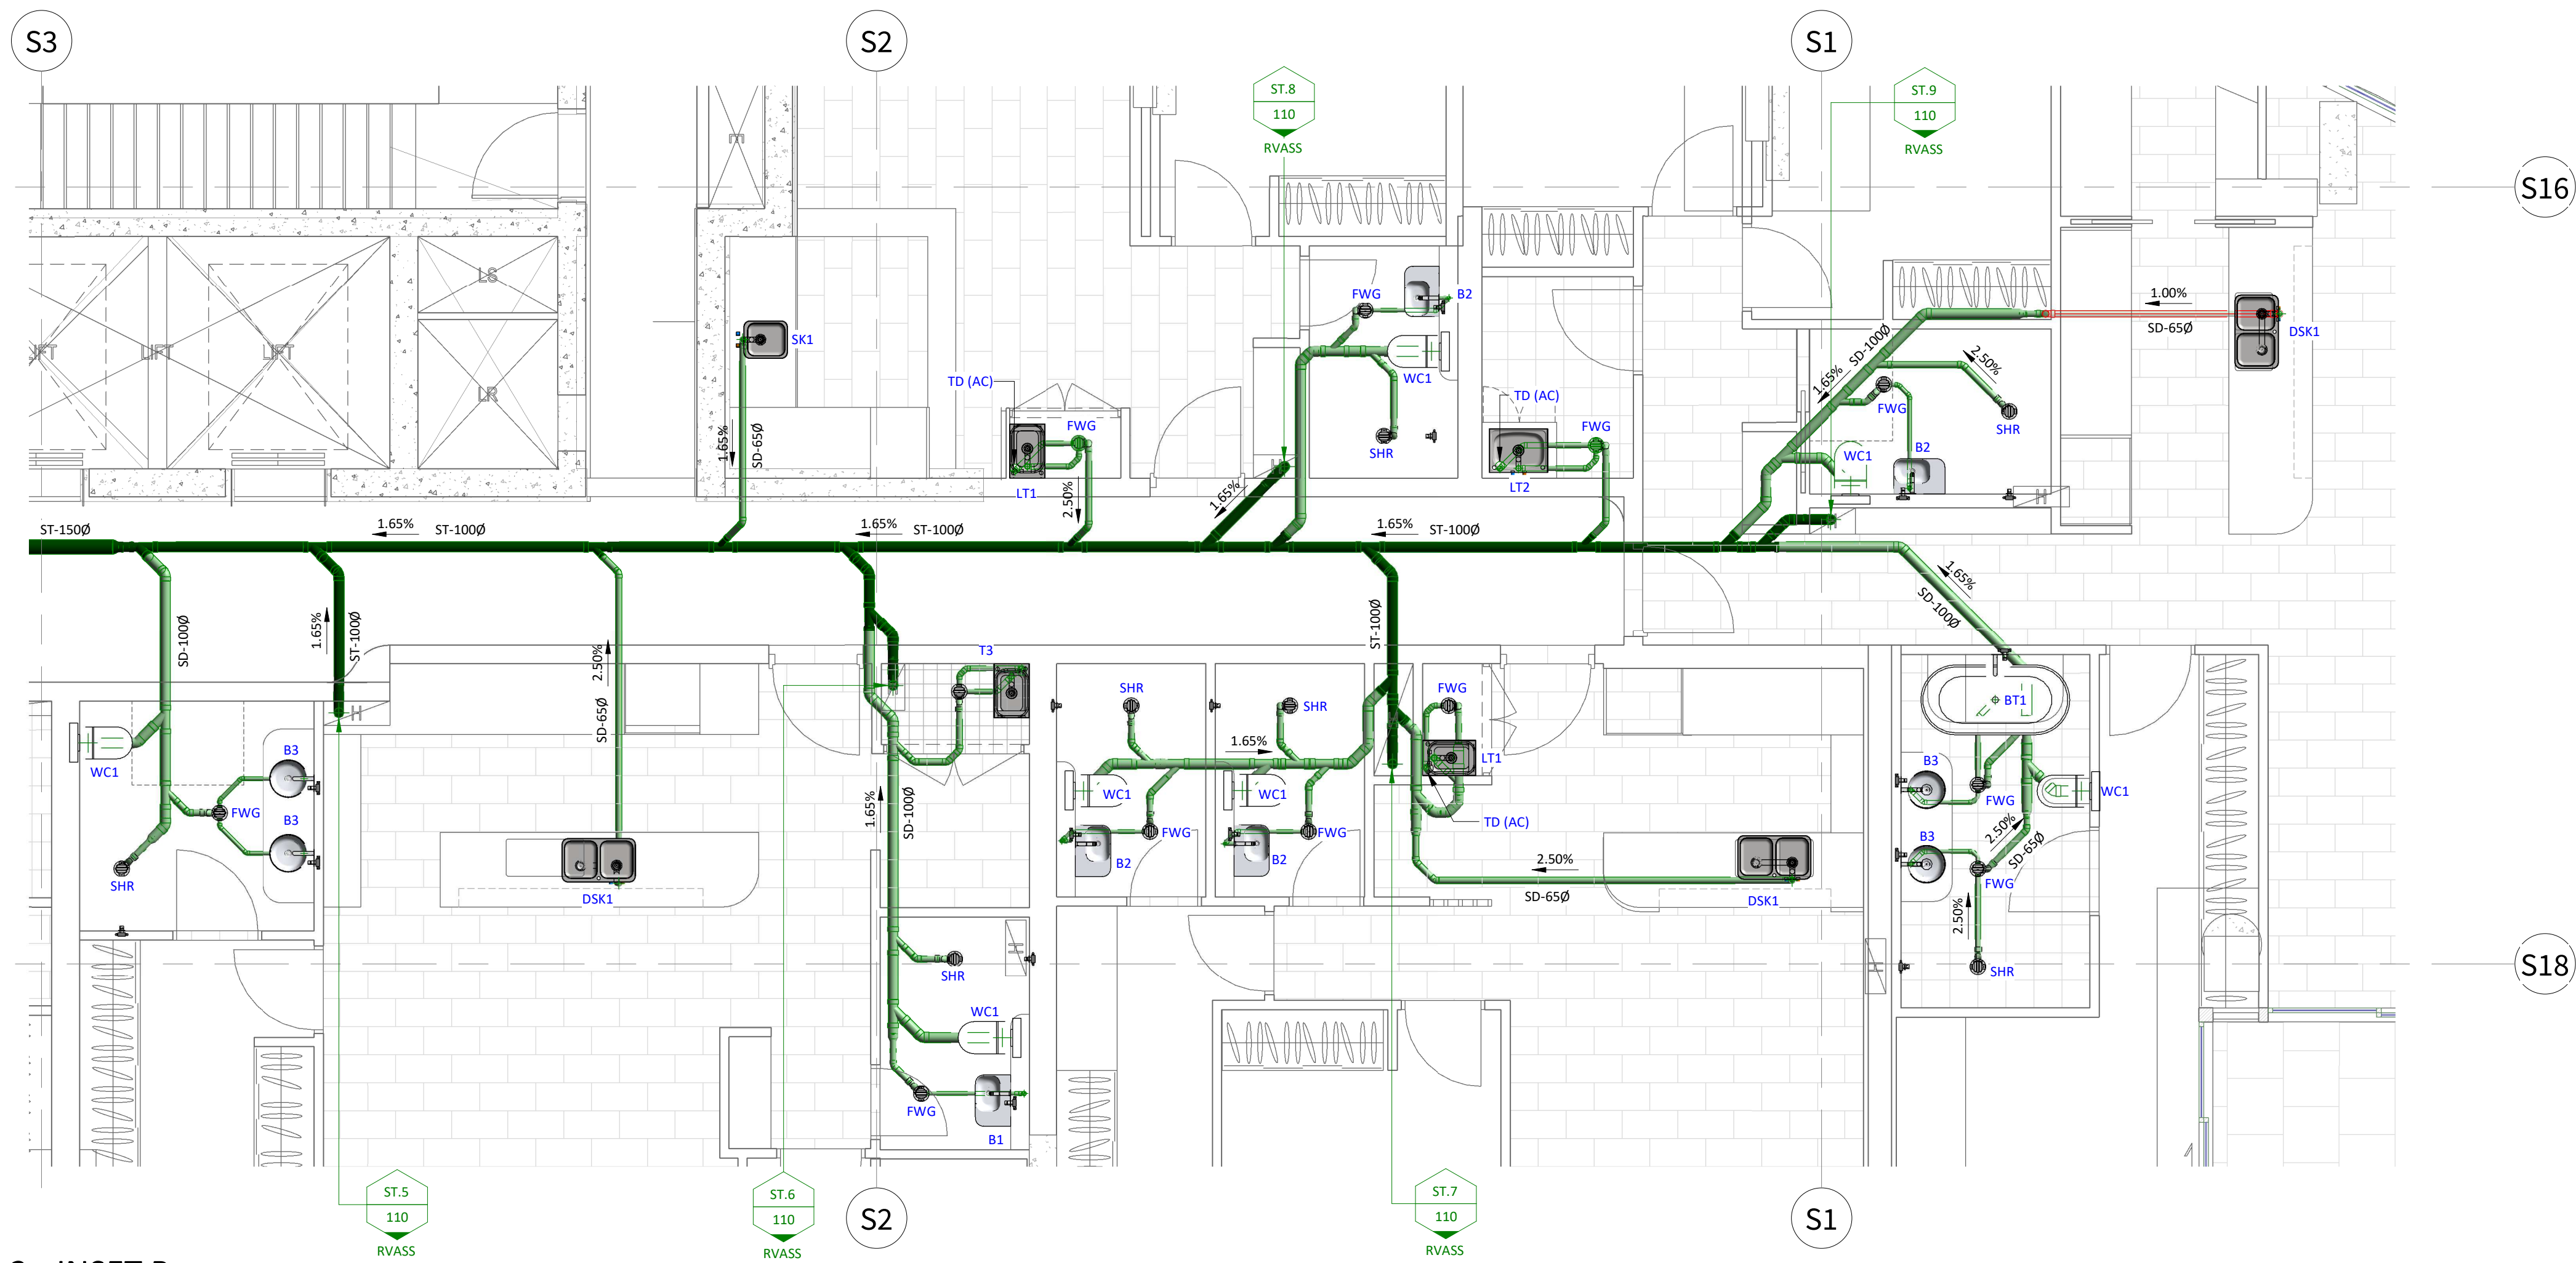

DRAINAGE PLAN - LEVEL 2 - INSET B
1 : 50

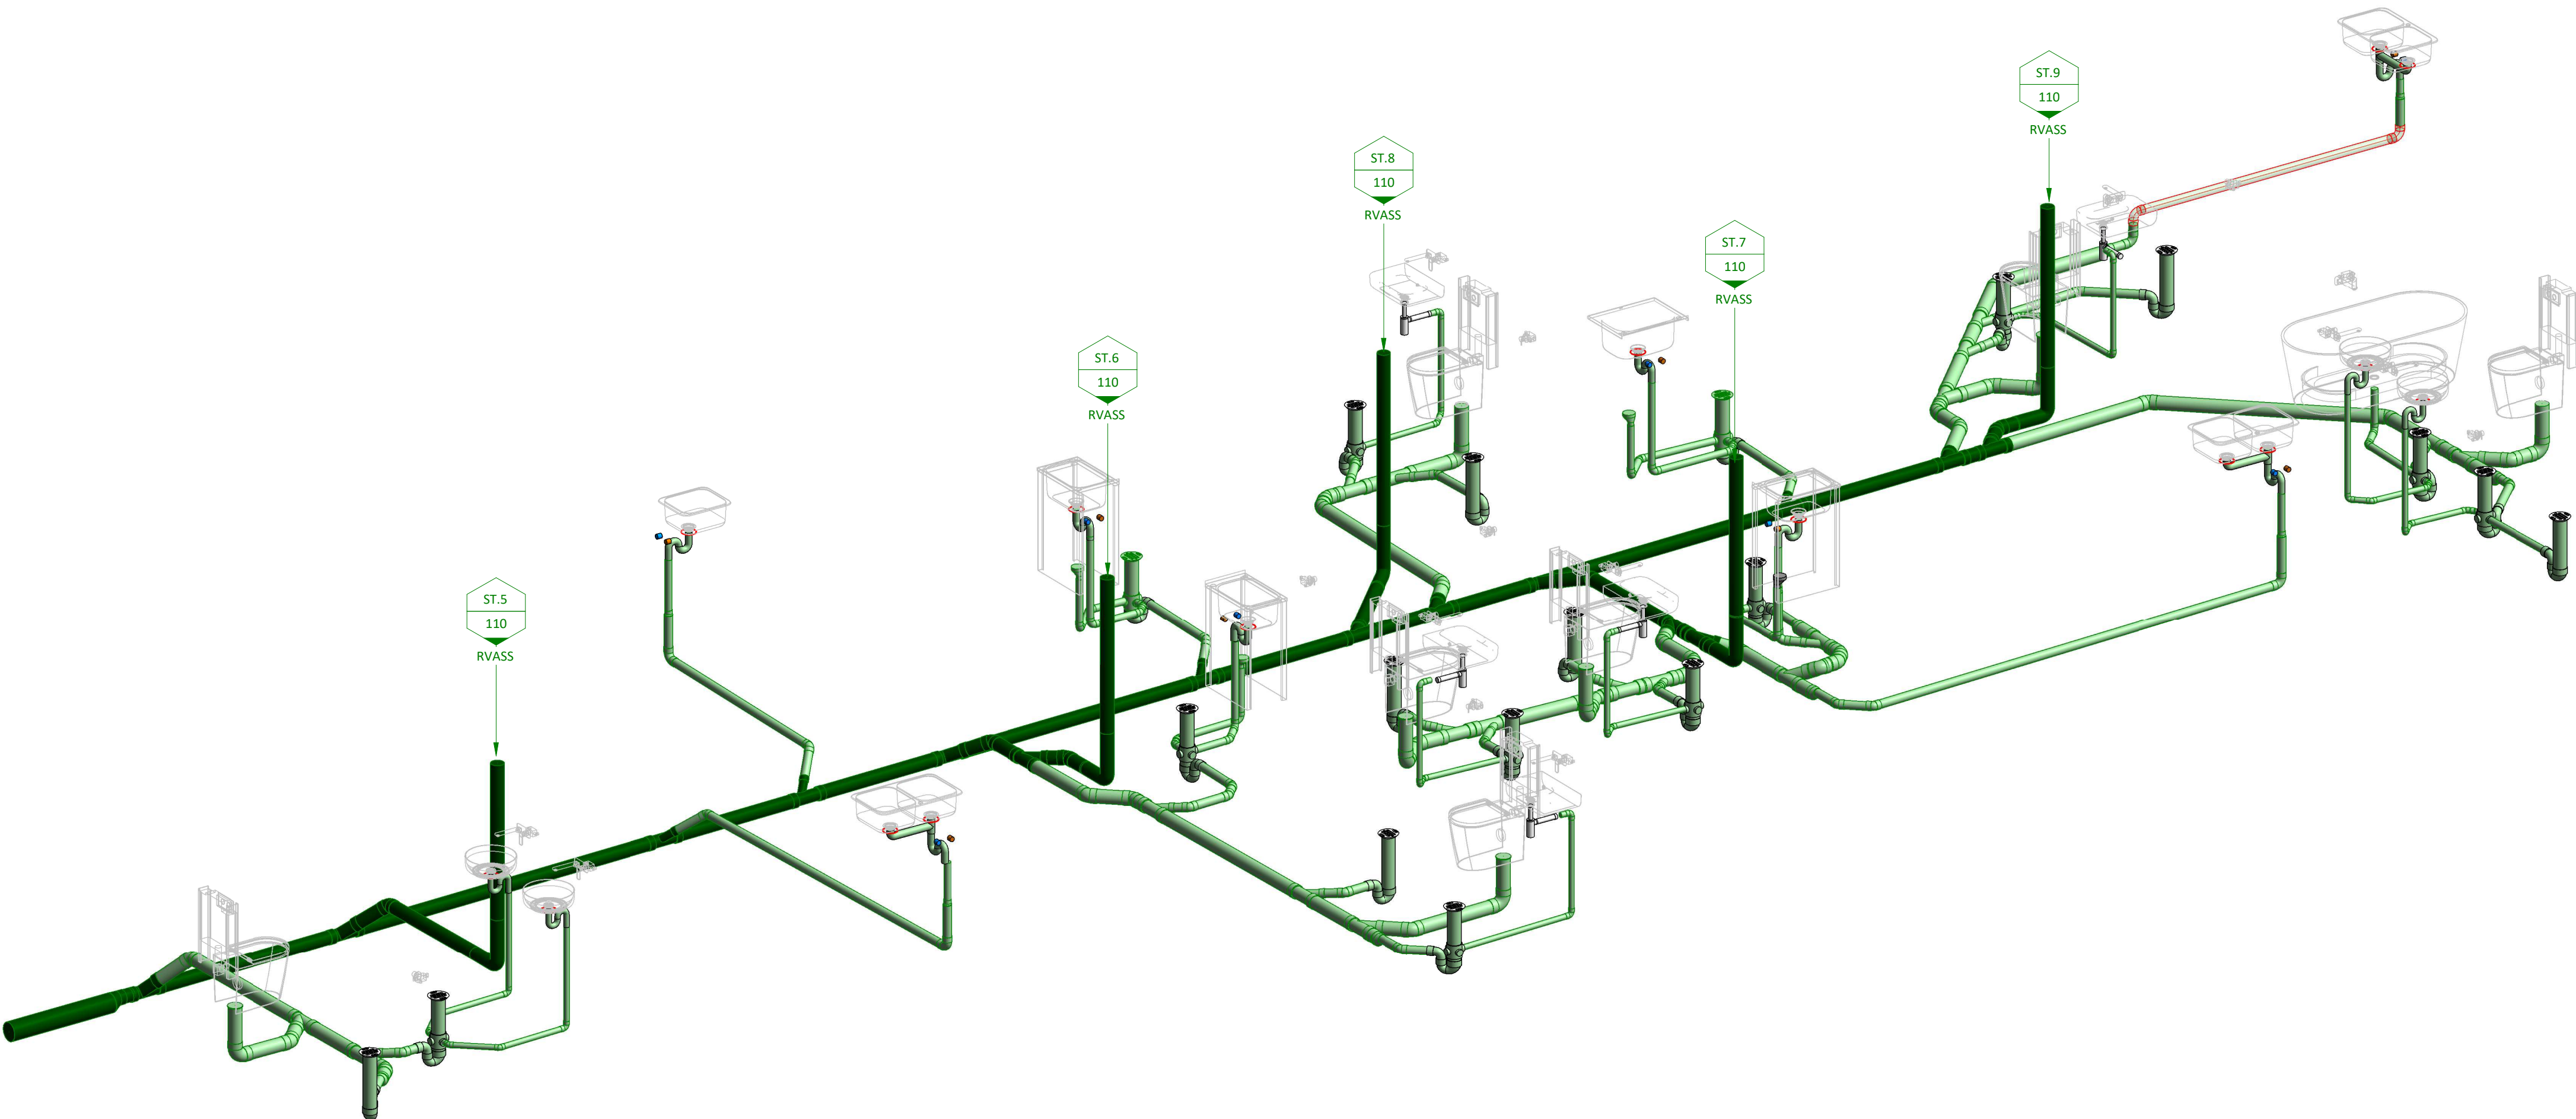

DRAINAGE PLAN - LEVEL 2 - INSET B - 3D SCHEMATIC
NOT TO SCALE

DRAINAGE PLAN
FREEHOLD TITLE
No. of Fixtures: Total Fixture Units:
Designed to comply with Plumbing and Drainage Act 2018.
Services designed to comply with:
Cold Water to AS3500.1.2
Hot Water to AS3500.4.2
Sanitary Plumbing & Drainage to AS3500.2.2
Trade Waste Drainage to AS3500.2.2
Fire Service to AS2419.1
Fire Hose Reel to AS2441

P1	ISSUE	XX/XX/XX	J.G.



RPD

Client

Architect/Client

Hydraulic Consultant

AQUALOGICAL
Plumbing Design Solutions


QBCC License No: 1099893
A.C.N.: 116 871 544
A.B.N.: 241 1687 1544
Unit B5, Commercial Court
130 Kingston Rd, Qld 4119
PO Box 220 Rochdale South 4123
(07) 3208 5233
admin@aqualogical.com.au
www.aqualogical.com.au

Project
RESIDENTIAL TOWER
TOWER ADDRESS


LEVEL 02
DRAINAGE SERVICES
DRAINAGE DETAIL PLAN L02

Drawn Validated


Scale 1:50 @ A1 1:100 @ A3

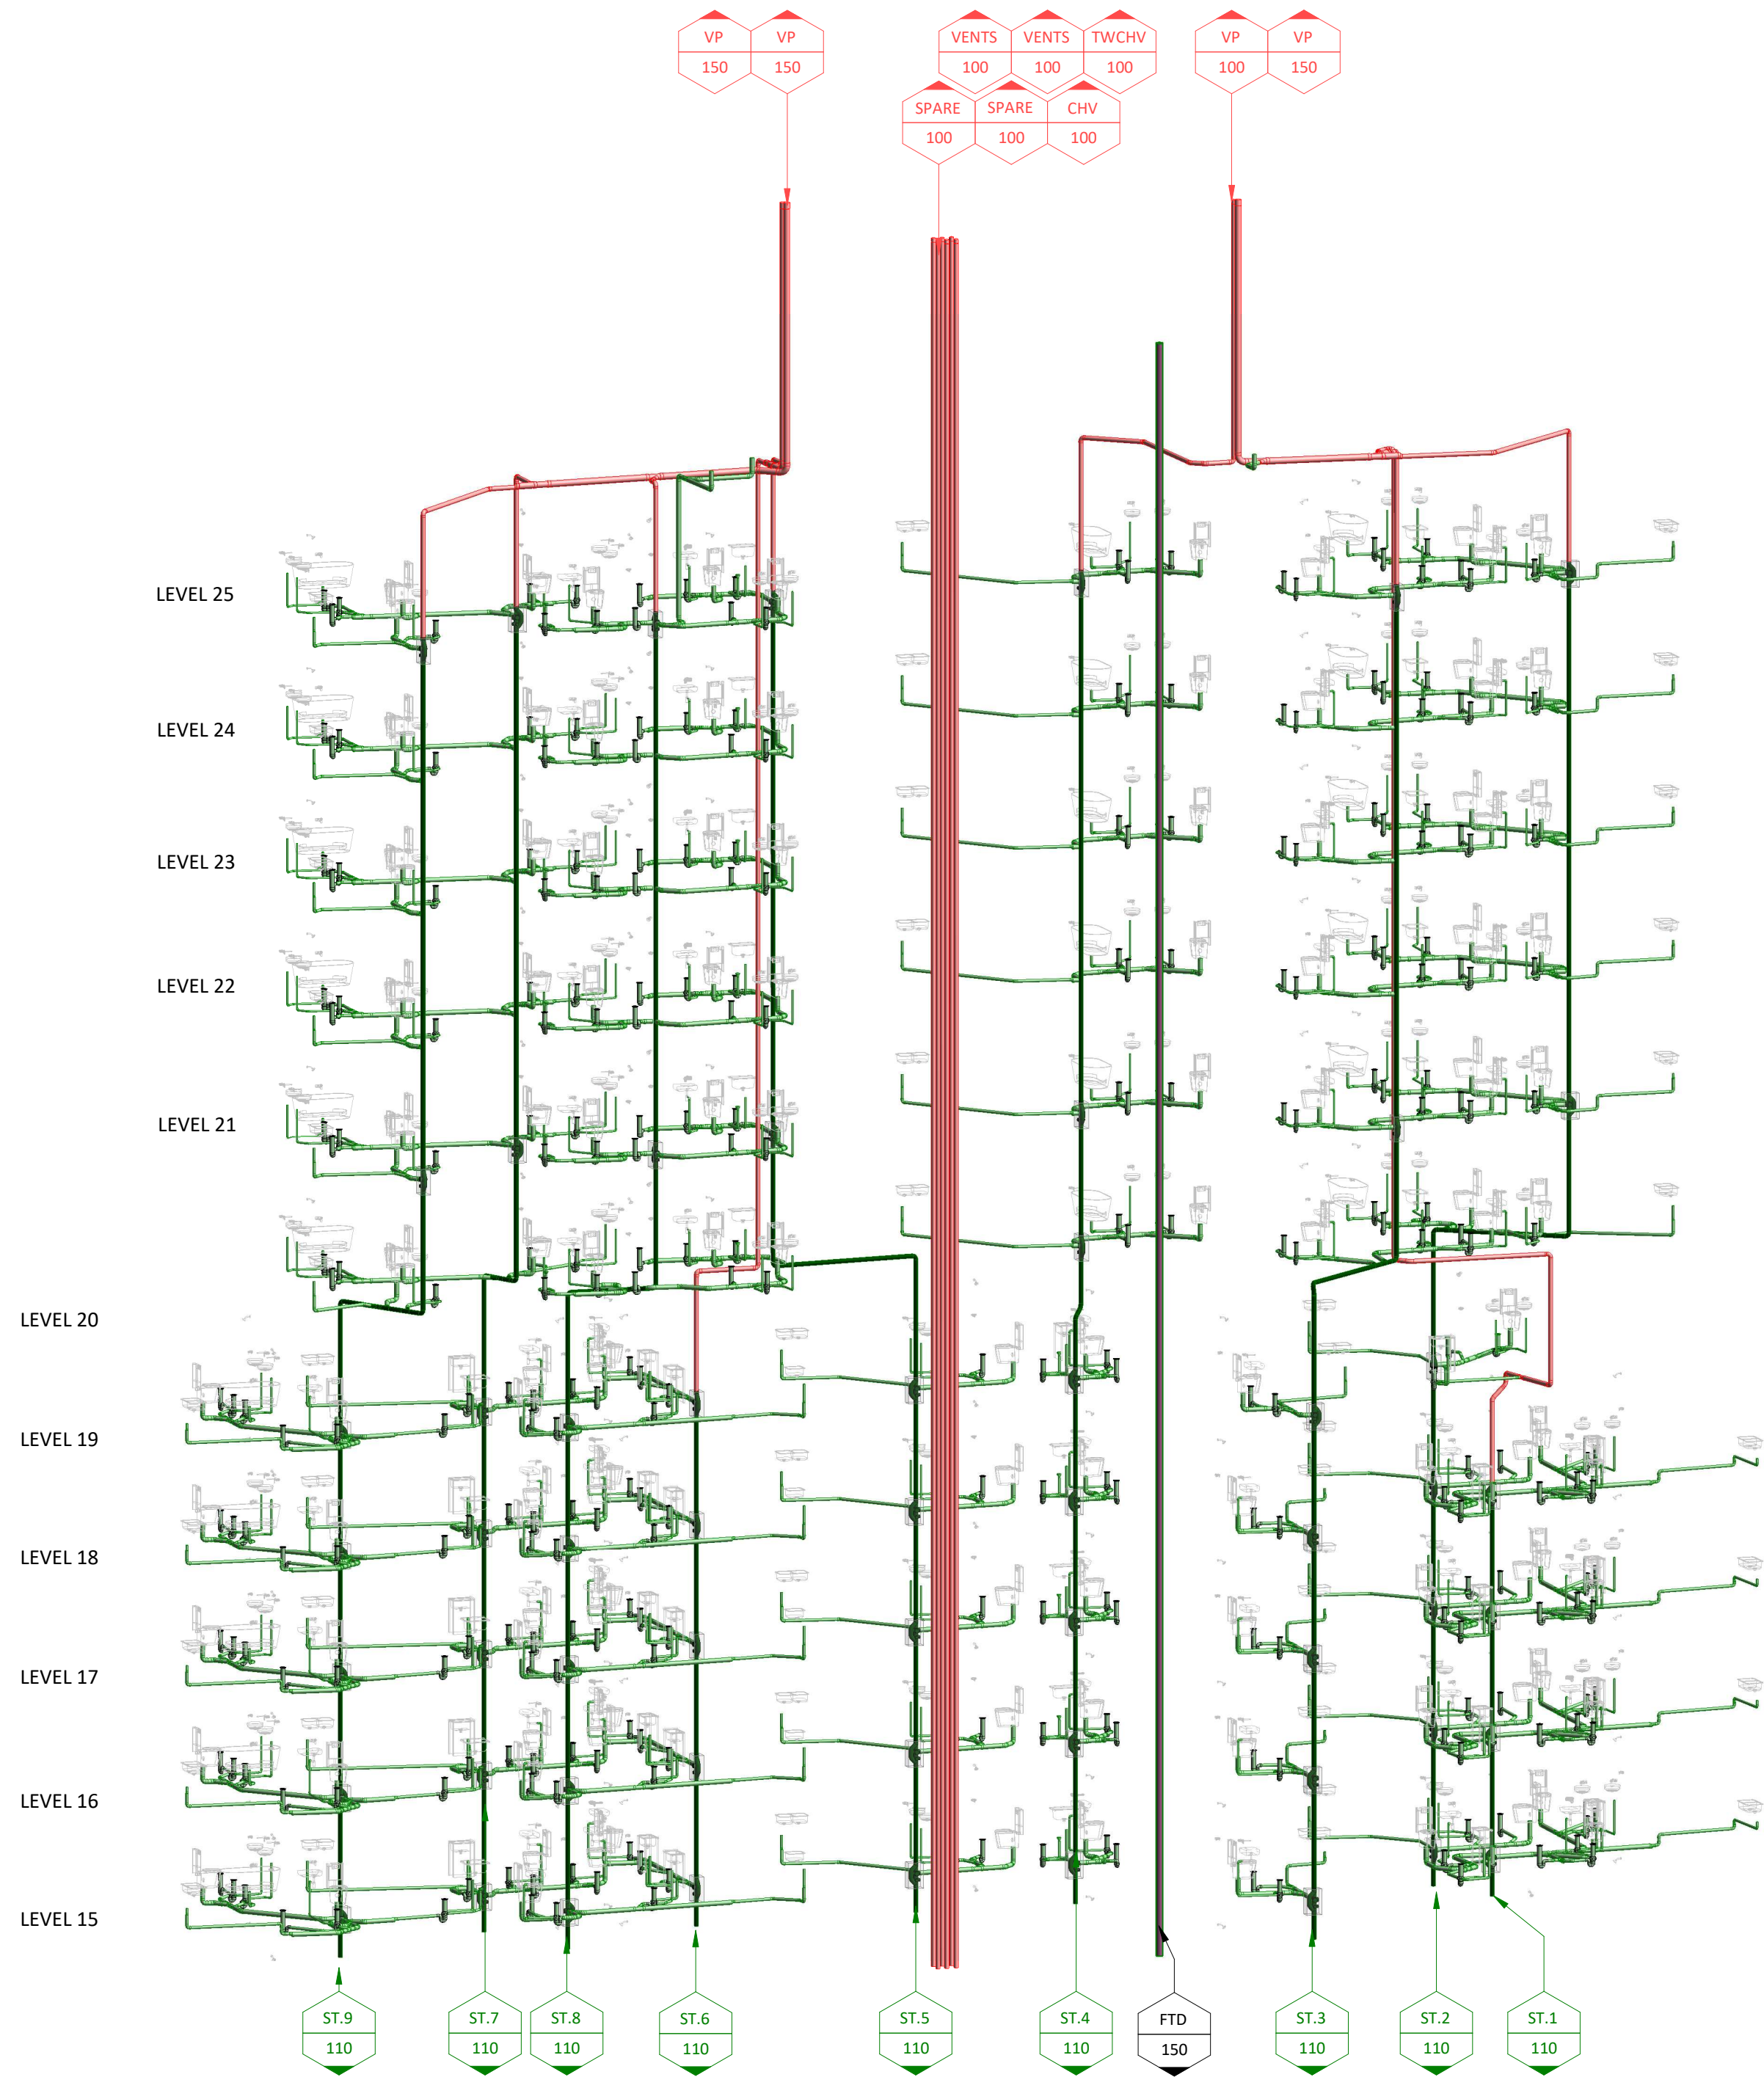

DRAINAGE - L15-ROOF - 3D DIAGRAM
NOT TO SCALE

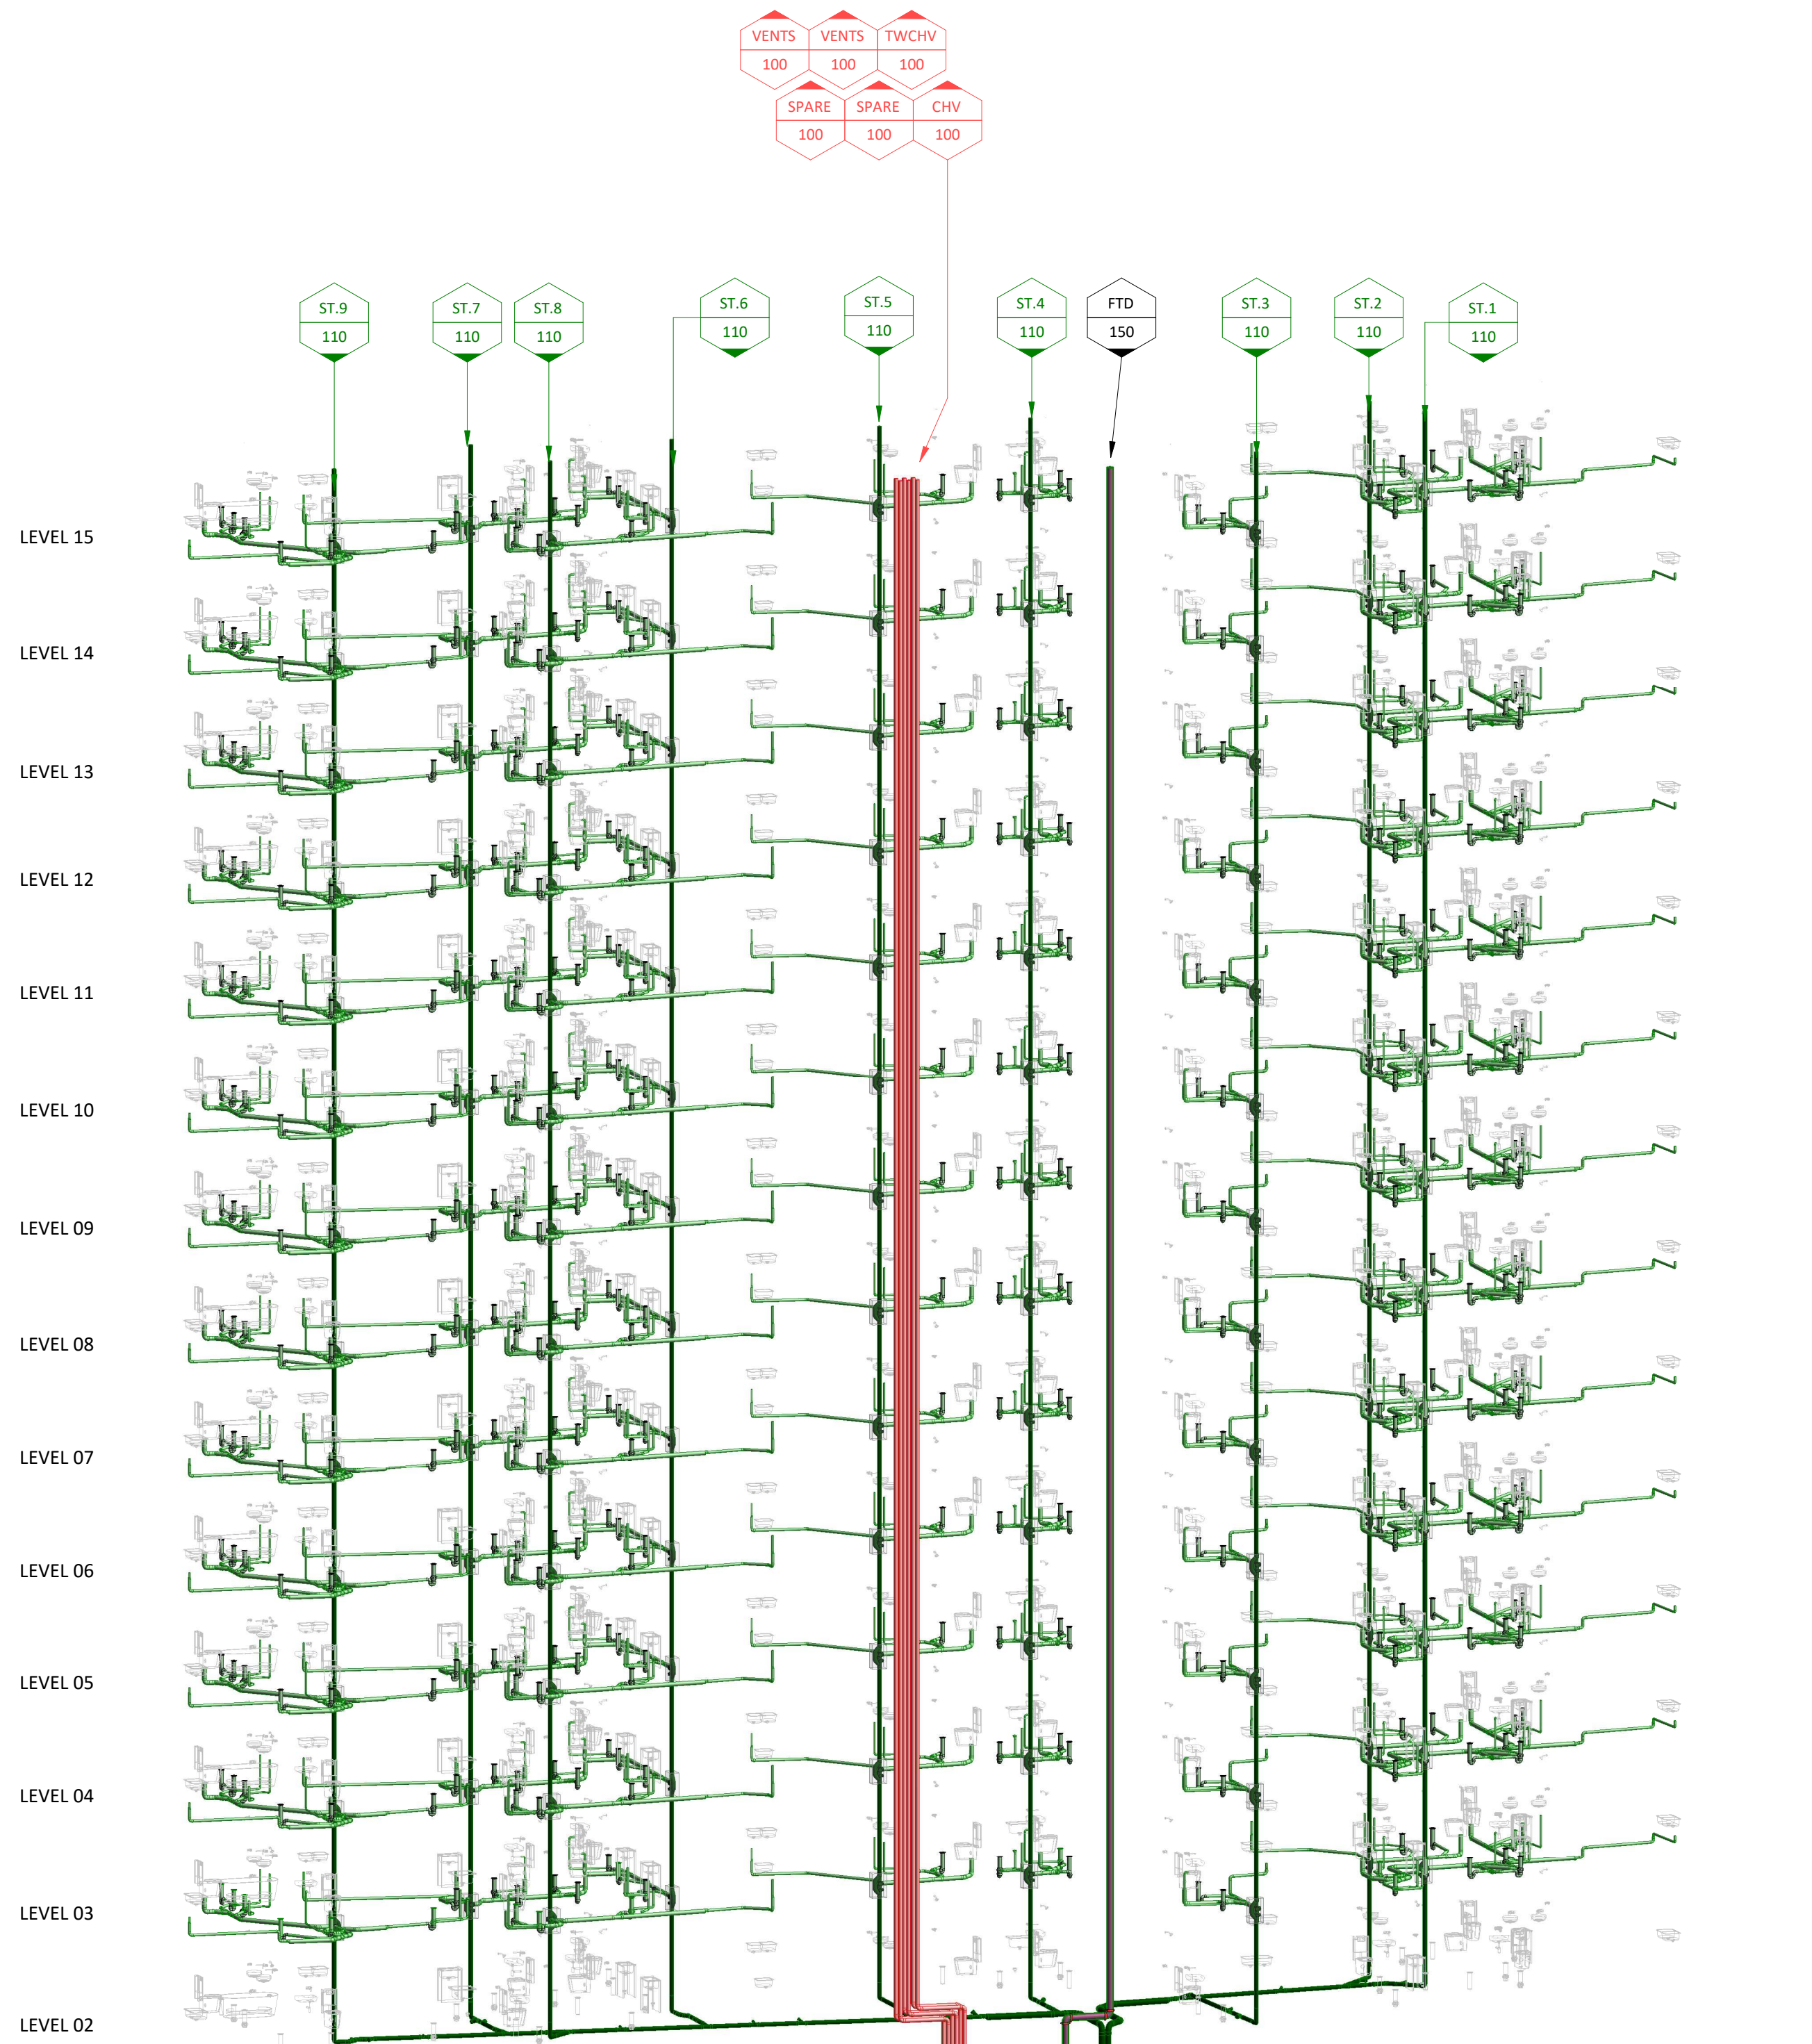

DRAINAGE - B03-L15 - 3D DIAGRAM
NOT TO SCALE

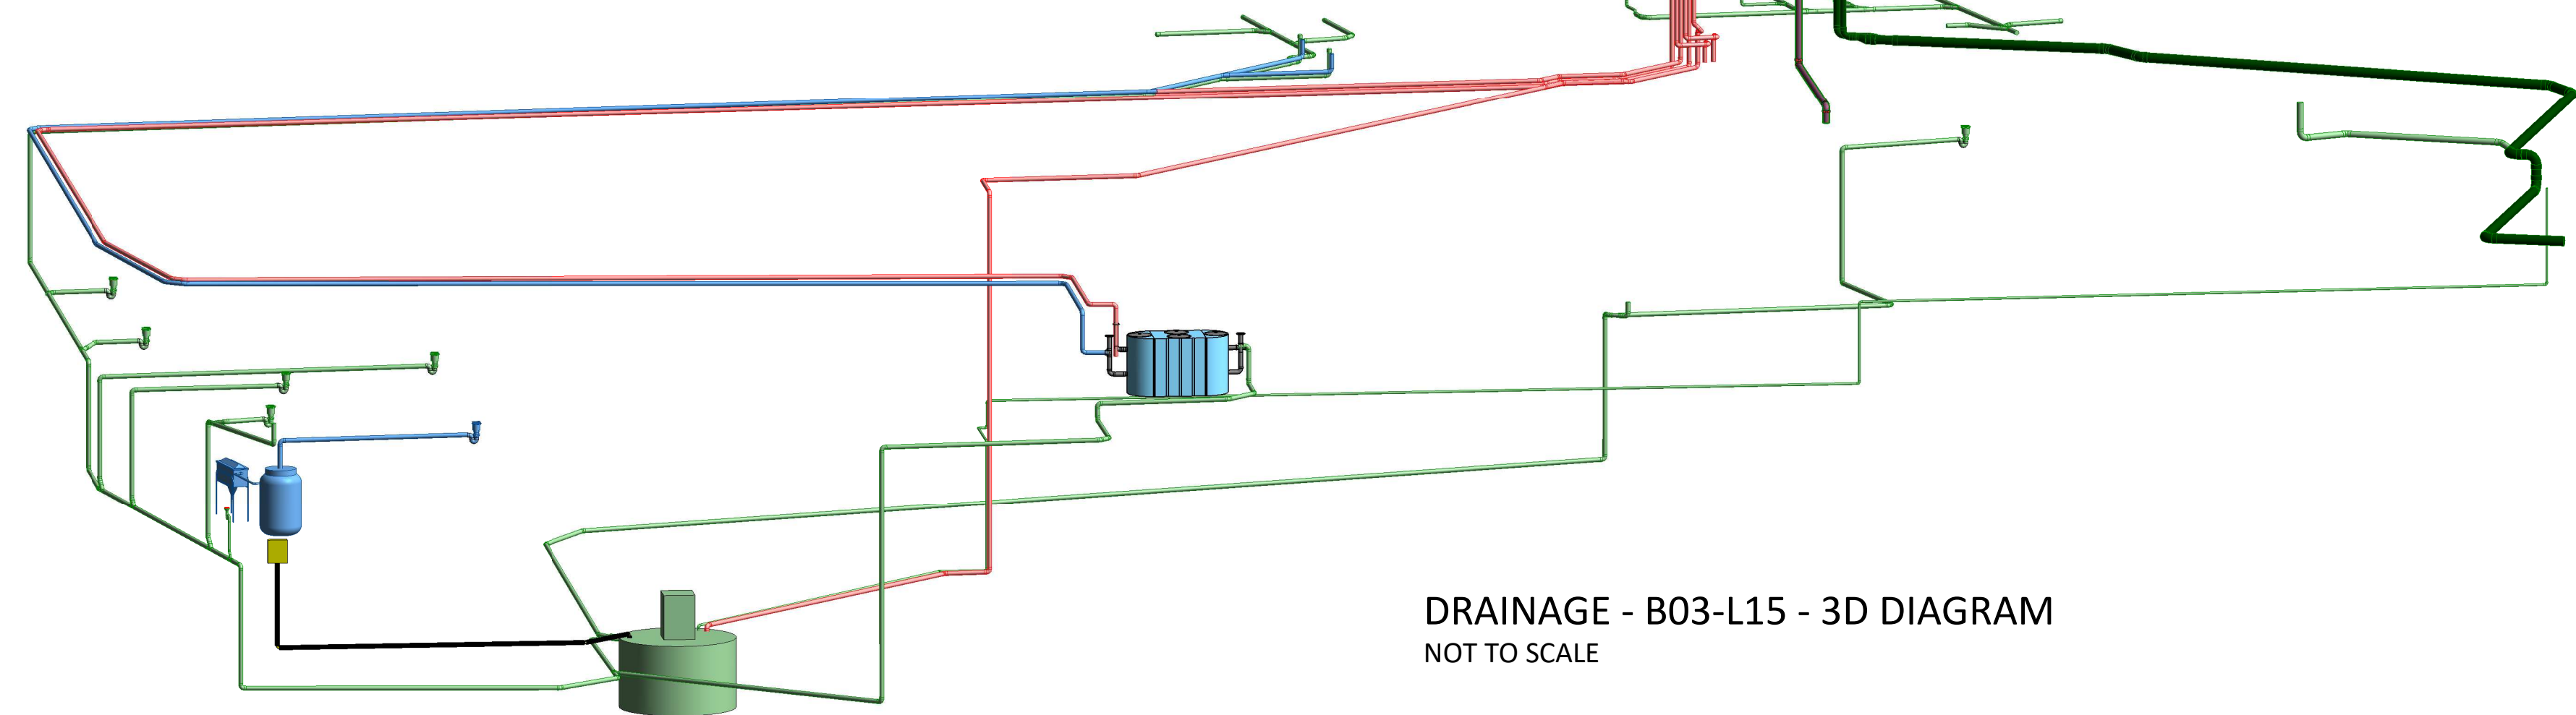

DRAINAGE PLAN
FREEHOLD TITLE
No. of Fixtures: Total Fixture Units:
Designed to comply with Plumbing and Drainage Act 2018.
Services designed to comply with:
Cold Water to AS3500.1.2
Hot Water to AS3500.4.2
Sanitary Plumbing & Drainage to AS3500.2.2
Trade Waste Drainage to AS3500.2.2
Fire Service to AS2419.1
Fire Hose Reel to AS2441

P1	ISSUE	XX/XX/XX	J.G.

Locality Plan

RPD

Client

Architect/Client

Hydraulic Consultant

QBCC License No: 1099893
A.C.N.: 116 871 544
A.B.N.: 241 1687 1544
Unit B5, Commercial Court
130 Kingston Rd, Qld 4119
PO Box 220 Rochedale South 4123
(07) 3208 5233
admin@aqualogical.com.au
www.aqualogical.com.au

Project
RESIDENTIAL TOWER
TOWER ADDRESS

ALL LEVELS
DRAINAGE SERVICES
DRAINAGE - 3D DIAG

Drawn Validated

Scale NOT TO SCALE